




Office Plan - Level 00
1 : 200

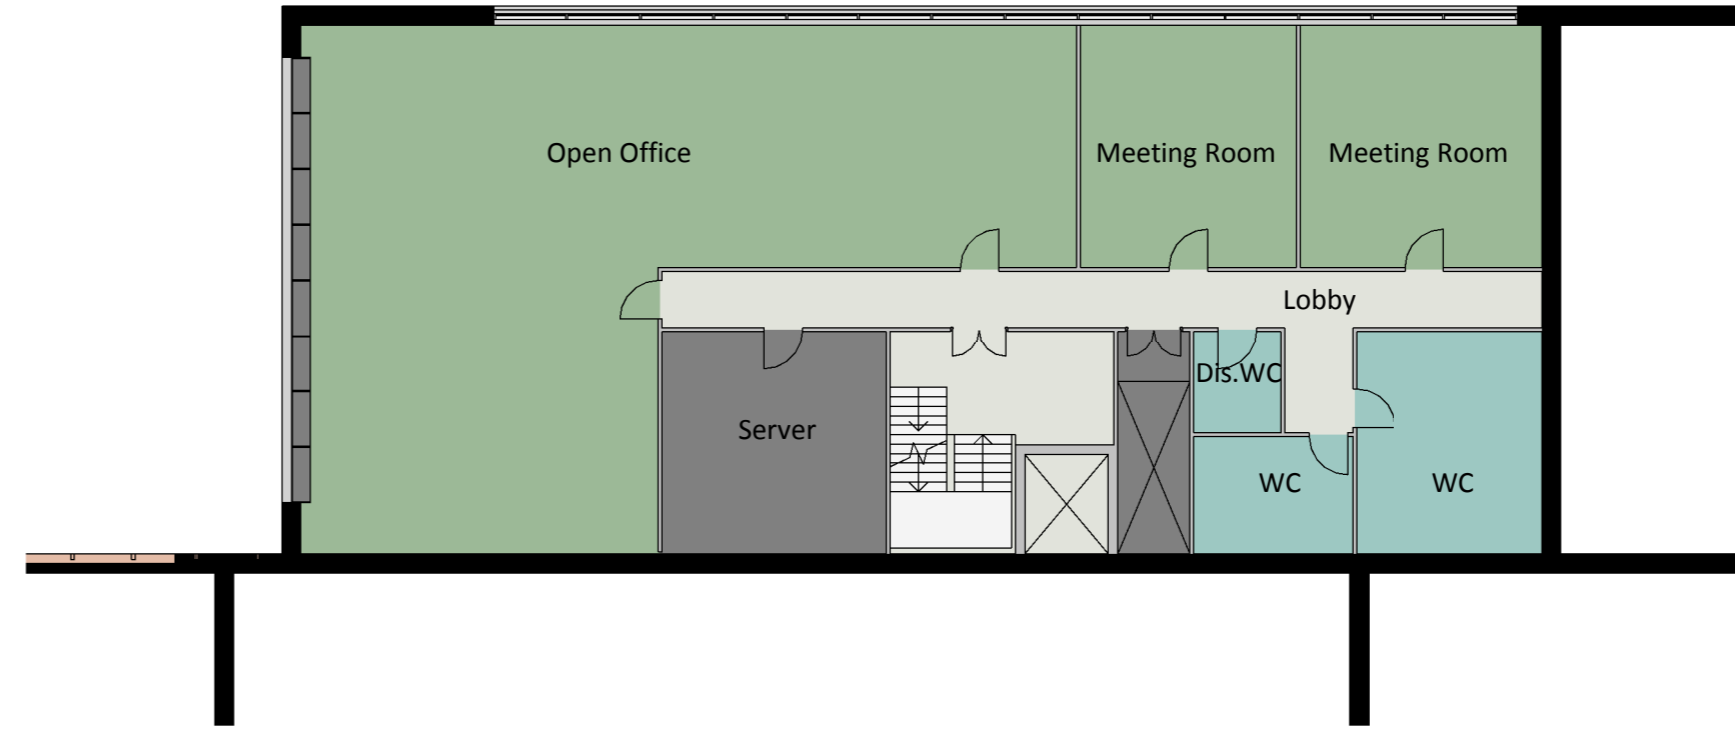


Office Plan - Level 01
1 : 200

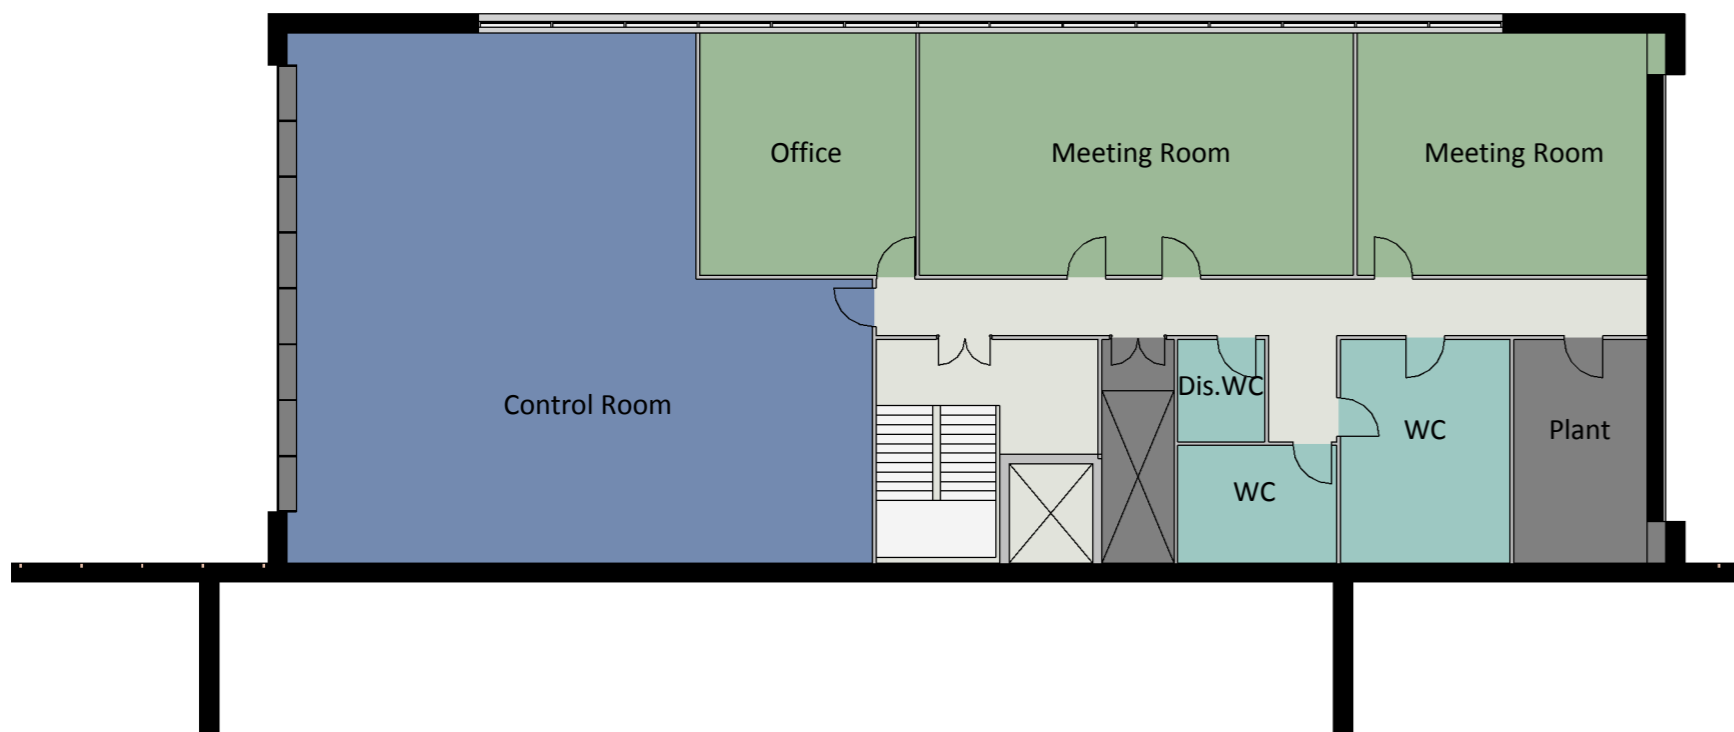

Office Plan - Level 03
1 : 200

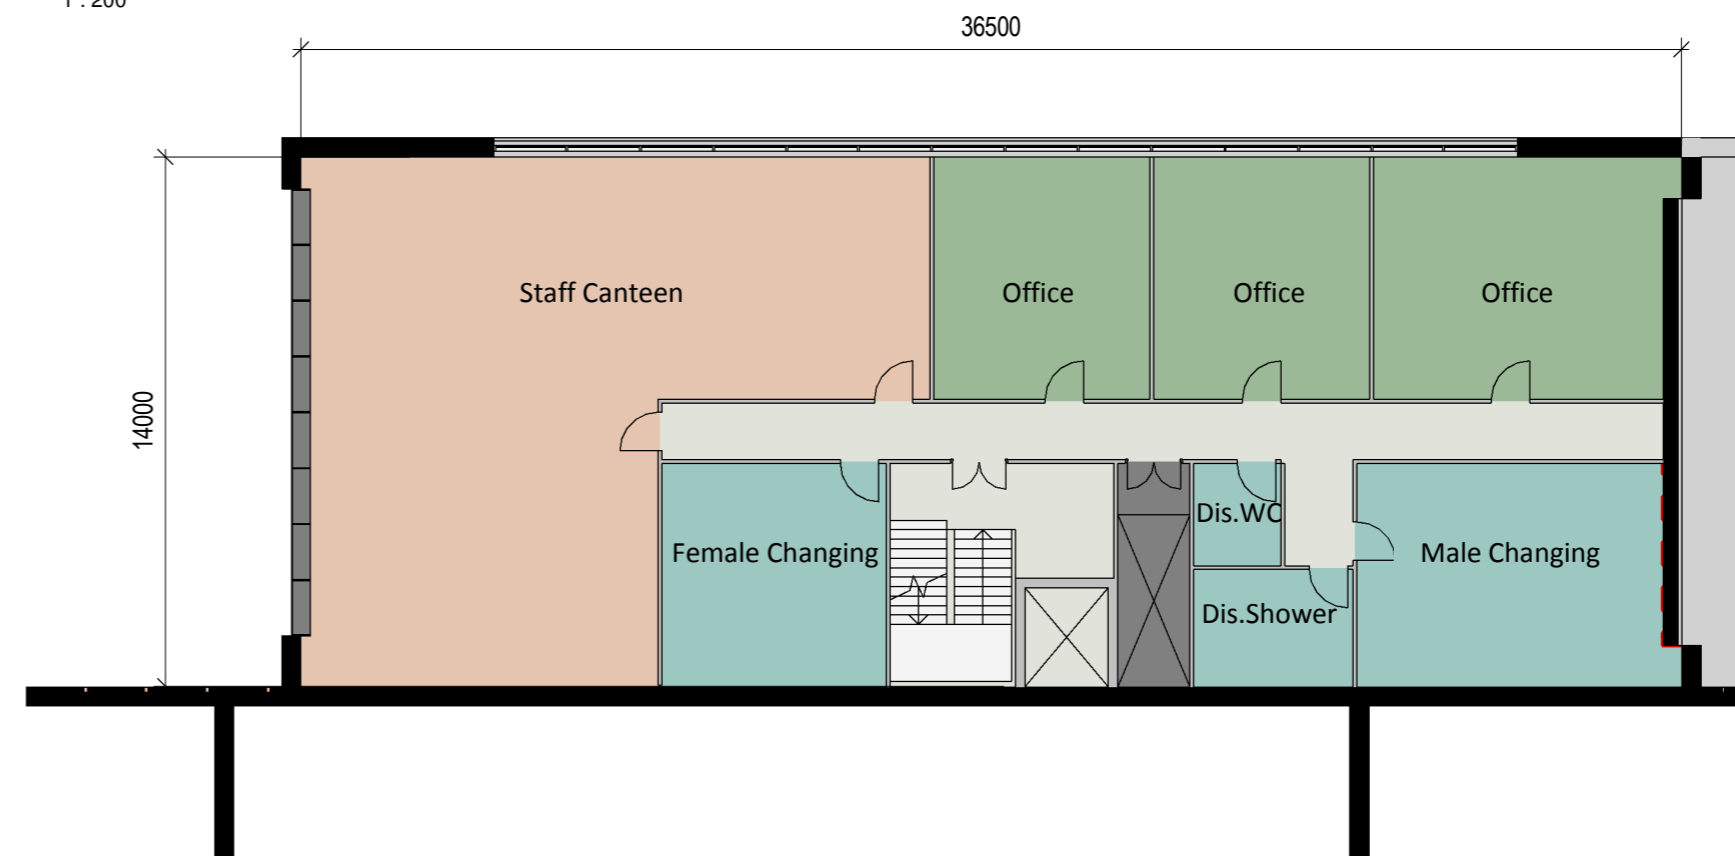

Office Plan - Level 02
1 : 200

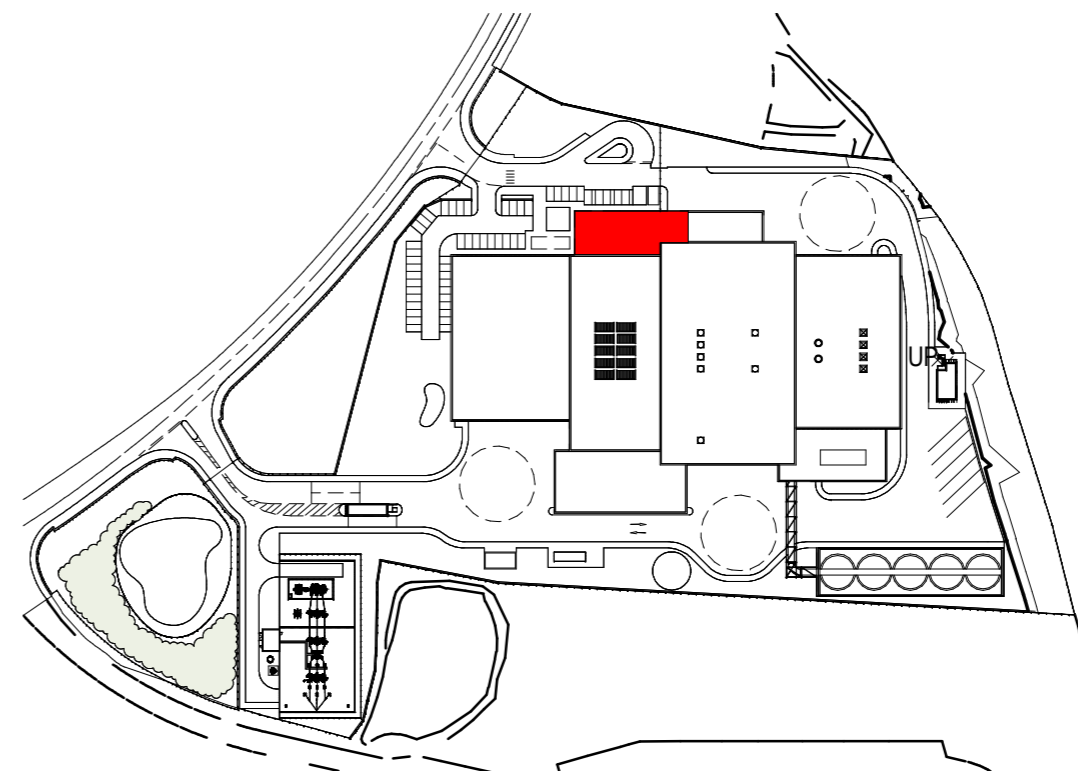

Office Plan Key

General Notes



All site dimensions shall be verified by the Contractor on site prior to commencing any works.

Do not scale from this drawing.

Only work to written dimensions.

This drawing is the property of Fletcher-Rae (UK) Limited (t/a Fletcher-Rae) and copyright is reserved by them. The drawing is not to be copied or disclosed by or to any unauthorised persons without the prior written consent of Fletcher-Rae (UK) Limited.

  PLANNING



Revision:

Scale	As indicated ¹ A2
Status	Planning
Drawn By	AE
Checked By	JC
Date	19/12/18

Client:

Veolia

Project:

Heysham Gateway ERF

Sheet Name:

Proposed Zoned Floor Plans

Drawing

Number:

18011_PL203

fletcher|rae

Architects | Master Planners | Designers

Hill Quays, 5 Jordan Street, Manchester, M15 4PY

t +44 (0) 161 242 1140
f +44 (0) 161 242 1141
w www.fletcher-rae.com
e info@fletcher-rae.com

Revision: